
 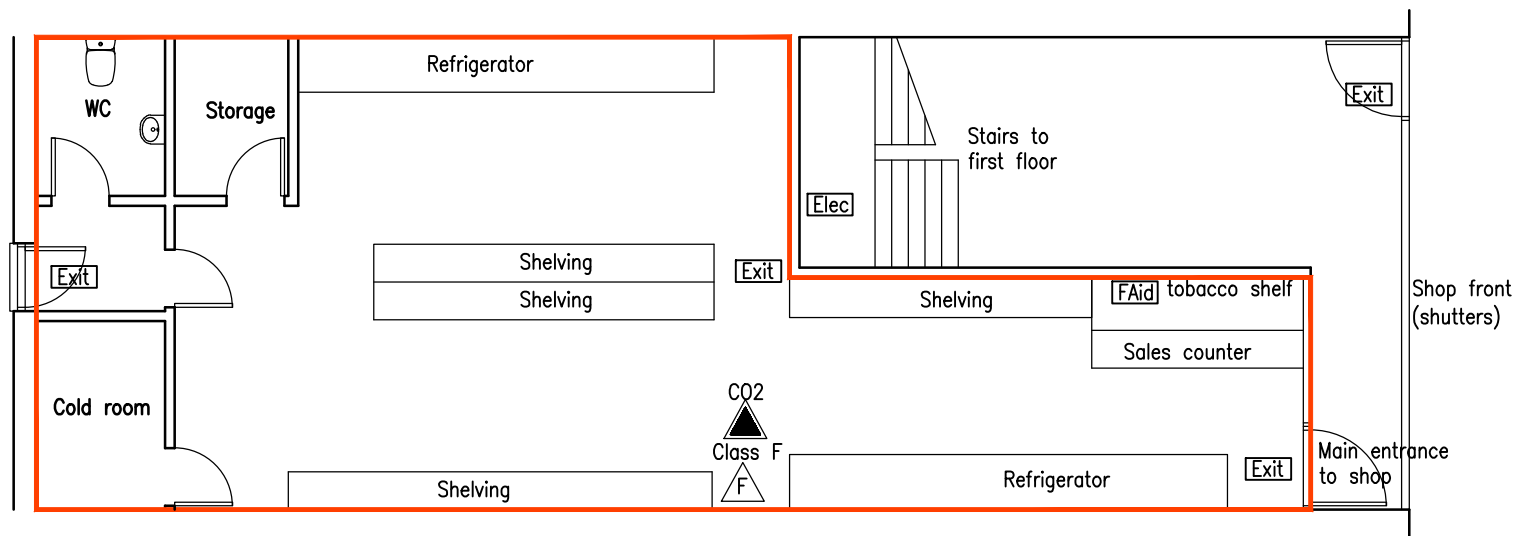




GROUND FLOOR PLAN

Scale 1:100

KEY TO PLAN

- FAid First Aid box
- Exit Fire Exit Light and sign
- Class F
F Class F (Foam) fire extinguisher
- CO2
▲ Carbon dioxide fire extinguisher
- Elec Electrical board

Revisions

T Joseph Associates Limited Chartered Architect 13 Penshurst Green Bromley Kent BR2 9DG T 020 8460 1036 E info@tjosephassociates.co.uk W www.tjosephassociates.co.uk		Client: PEACO MINI MARKET	Title: GROUND FLOOR PLAN		
Project: 4 LIBRARY PARADE CRAVEN PARK LONDON NW10 SG		Project Ref. 4LIBR	Drawing no: 01	Revision:	Date: DEC 2019 Scale: 1:100/A4