




KINGSLEY ADJET

Handwritten signature



LAST FORMER BUSINESS


GILLIAN RADFORD &
CO.

453 Harrow Road
London W1C 4RG

-  Fire extinguisher
6 Litre AFFF Foam spray
-  9 Litre Water stored
pressure
-  6 kg (abc) powder


 EL Emergency Lighting

 CCTV
 Closed Circuit Television
camera

 Licensable Activities

 EMERGENCY EXIT

 SITTING /CHAIRS/TABLES

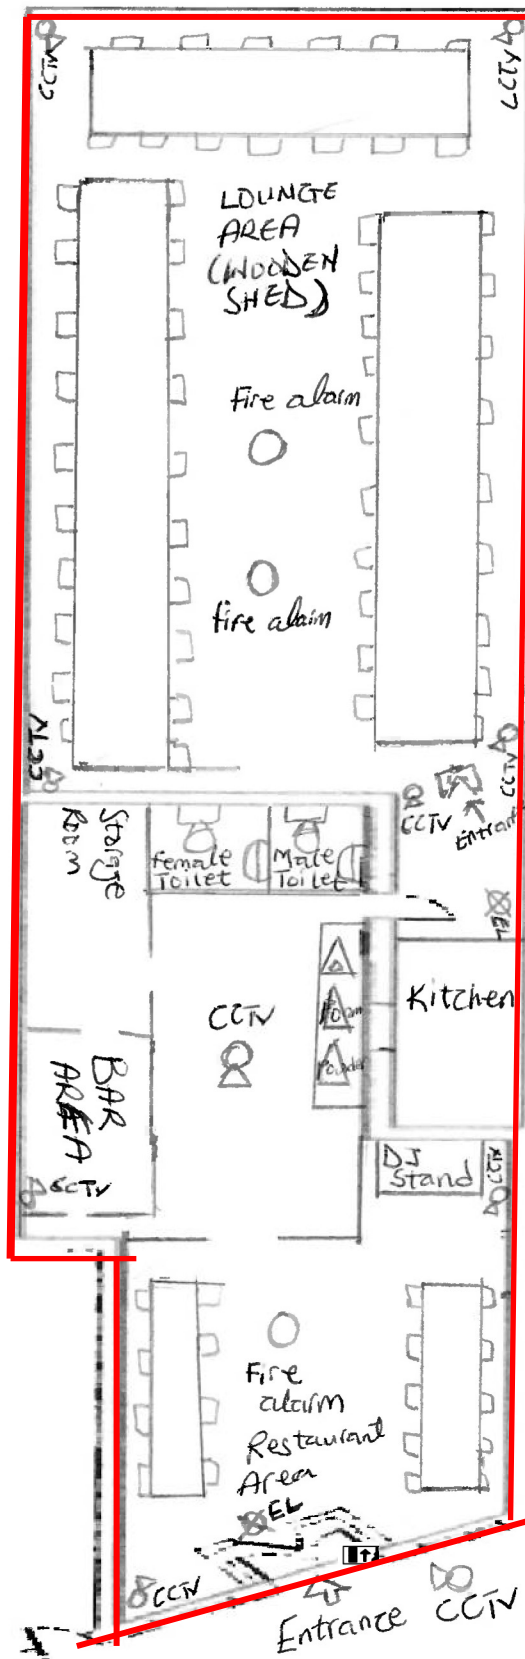

LEASE PLANNERS
WWW.LEASEPLANNERS.CO.UK

OFFICE 0203 637 0150

EMAIL: sales@leaseplanners.co.uk

DRAWING TITLE
1 CRAVEN PARK
ROAD
LONDON
NW108SE


DATE 5th December 2022

RED OUTLINED AA
ARE PART OF THE PREMISES

scale: 1:100 at A4



SCALE For the plan to be to scale, the above scale bar
must measure correct when printed (for example 5cm)

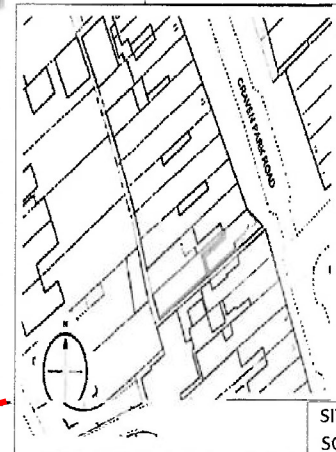

SITE PLAN
SCALE 1:1250