


- KEYS:**
- F.E - Fire Exit
  - FA - Fire Alarm
  - SD - Smoke Detector
  - FE - Fire Extinguisher (Foam)
  - FE - Fire Extinguisher (H2O)
  - CCTV - CCTV
  - First Aid equipment
  - Licensable activities

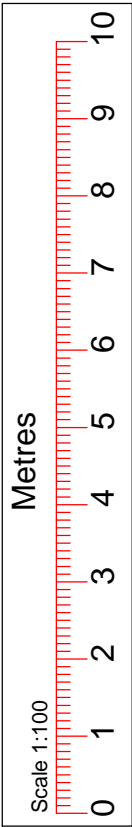

**SHOP FLOOR PLAN**  
Scale 1:100

TITLE : PREMISES PLAN.



Contact: M.Mathu(BSc, MSc Civil Engineering)  
Tel : 07515365953  
Email: mkmarchidesign@gmail.com

NAME :  
ADDRESS : 44 QUEENSBURY STATION PARADE,  
EDGWARE,  
HA8 5NN.

Notes: # This Drawing is Copyright of MKM ARCHI DESIGN LTD.  
# Contractor/Builder to check all dimension on site, Before commencement of any works. Figured dimension only to be used.  
# All work shall comply with the latest Building Regulations & be to the satisfaction of the L. Authority.  
# Materials shall be suitable for the purpose for which they are used & the quality shall not be lower than that defined in the relevant British standard.

Drg No : ARC/23/QUE44/SP02 | Scale : Shown@A4 | Drwn By: M.Mathu | Date : 13/06/2023 | Page : 01/01