
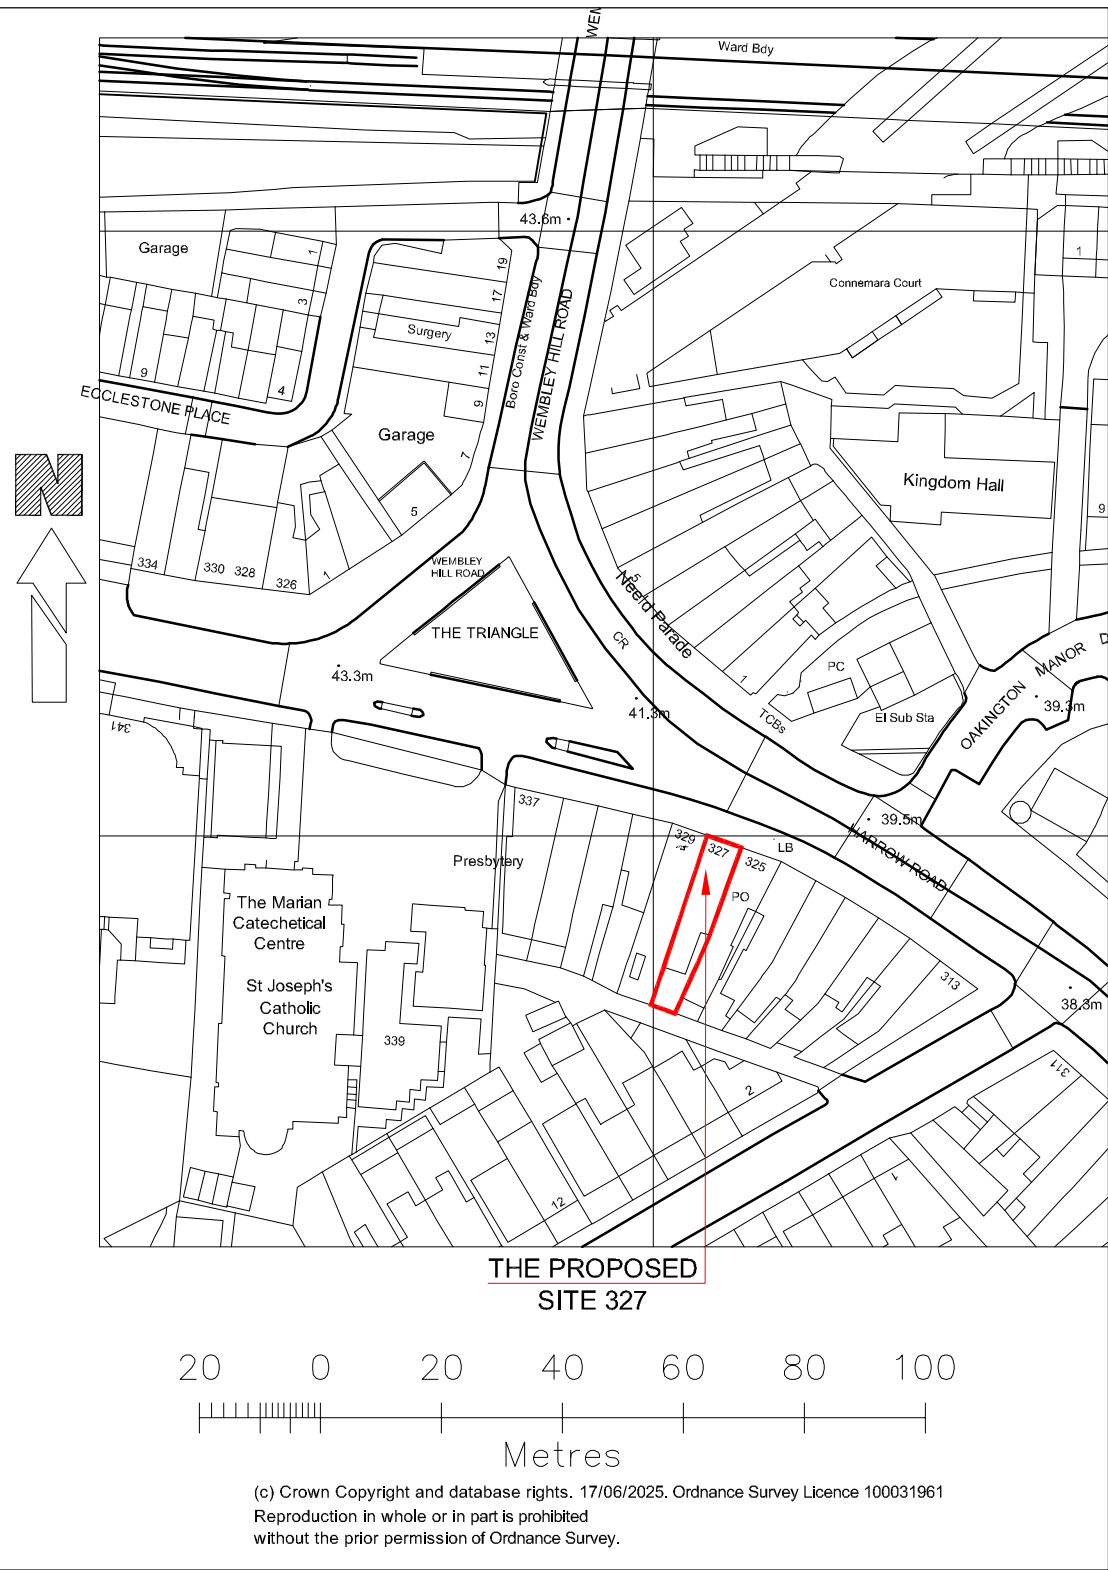


 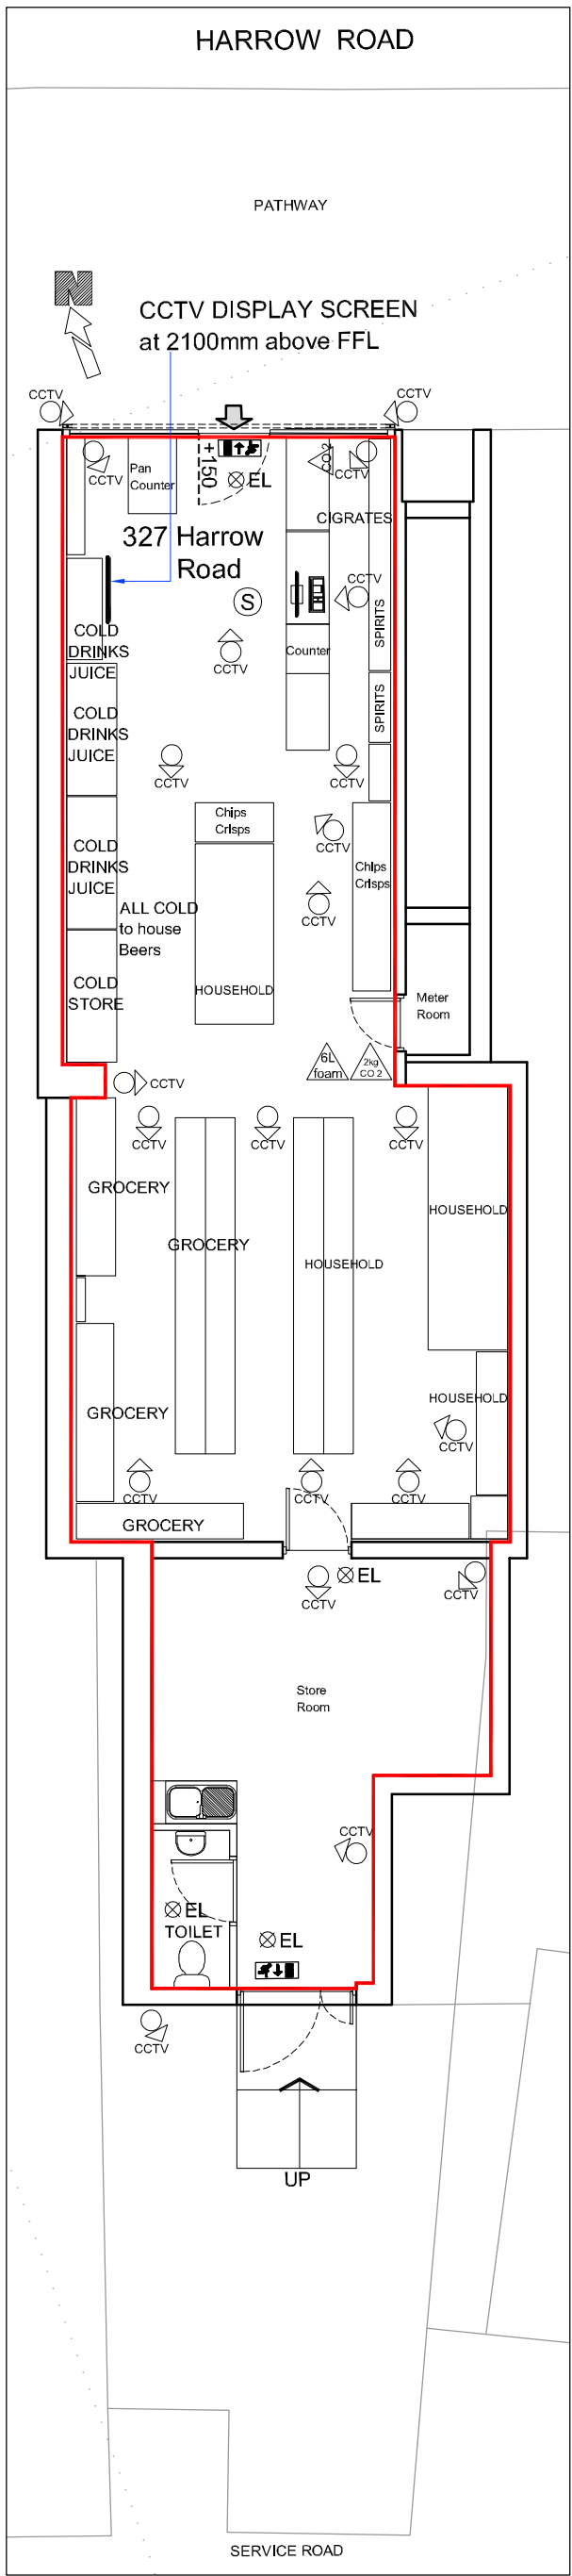


**SITE PLAN**  
SCALE 1:1250 @ A3

- Smoke Detectors underneath the structural existing slab
- Fire extinguisher 6 Litre AFFF Foam spray
- Fire extinguisher CO2
- Closed Circuit Television camera
- Emergency Lighting
- Licensable Activities

**PROPOSED GROUND FLOOR PLAN**

SCALE 1:100 @A3



**PREMISES LICENCE APPLICATION**

|                                                                                                                                                                                                                                                                                                                                        |  |            |  |                                                                                                                                             |             |                                                 |                                                                                    |
|----------------------------------------------------------------------------------------------------------------------------------------------------------------------------------------------------------------------------------------------------------------------------------------------------------------------------------------|--|------------|--|---------------------------------------------------------------------------------------------------------------------------------------------|-------------|-------------------------------------------------|------------------------------------------------------------------------------------|
| NOTES:                                                                                                                                                                                                                                                                                                                                 |  | REVISIONS: |  | S A I ARCHITECTS & ASSOCIATES-CONSULTANTS<br><br>62, Crownwalk, Wembley, Middlesex, London HA9 8HU<br>Tel 07961 743174 E:salarchi@yahoo.com |             | RIBA (Stage-A) from Inception to (L)-Occupation |                                                                                    |
| Figured dimensions are to be used in preference to scaled dimensions.                                                                                                                                                                                                                                                                  |  |            |  |                                                                                                                                             |             | TITLE/VIEW                                      | Proposed Ground Floor Plan                                                         |
| Contractors to verify all dimensions on site before commencing any work or shop drawing.                                                                                                                                                                                                                                               |  |            |  |                                                                                                                                             |             | PROJECT                                         | Planning- New Premises Licence                                                     |
| Any discrepancies between these drawing and any other documents, drawings and the actual situation encountered on site should be conveyed to SAI Architects & Associates - Consultants and / or contract administrator immediately.<br>This drawing is to be read in conjunction with other issued project documentation and drawings. |  |            |  |                                                                                                                                             |             | LOCATION                                        | SANGIT EXPRESS,<br>327 Harrow road, Wembley,<br>Middlesex, Brent<br>London HA9 6BA |
| All works to comply with the latest relevant code of practice, British Standards and Building Regulations and are to be the satisfaction of Local Statutory Authorities.                                                                                                                                                               |  |            |  | PROJECT NO.                                                                                                                                 | 25/PL-06/PL | DRAWN BY                                        | RJ                                                                                 |
| No part of this drawing may be reproduced without the permission of SAI Architects & Associates - Consultants. This drawing is the property of Client. It must not be copied in whole or in part or distributed without their written permission. Copyright is reserved ©.                                                             |  |            |  | DRAWING NO.                                                                                                                                 | 25/310/PL   | DATE                                            | 23/07/25                                                                           |
|                                                                                                                                                                                                                                                                                                                                        |  |            |  | SCALE                                                                                                                                       | 1:100       | REV.                                            | *                                                                                  |