

THIS DOCUMENT IS THE PROPERTY OF BDP. IT IS TO BE USED ONLY FOR THE PROJECT AND NOT TO BE REPRODUCED OR TRANSMITTED IN ANY FORM OR BY ANY MEANS, ELECTRONIC OR MECHANICAL, INCLUDING PHOTOCOPYING, RECORDING, OR BY ANY INFORMATION STORAGE AND RETRIEVAL SYSTEM. WITHOUT THE WRITTEN PERMISSION OF BDP.

FOR MORE INFORMATION, CONTACT: BDP PROJECTS
 11 DUNE STREET
 PRESTON, NORTH WEST
 LANCASHIRE, ENGLAND
 M35 9NF
 TEL: +44 (0)151 422 2200
 WWW.BDP.COM

NOTES


REV	DATE	BY	CHK	DESCRIPTION
01	11/03/17
02	11/03/17
03	11/03/17
04	11/03/17
05	11/03/17

BDP.

11 DUNE STREET
 PRESTON, NORTH WEST
 LANCASHIRE, ENGLAND
 M35 9NF
 TEL: +44 (0)151 422 2200
 WWW.BDP.COM

60X PARK, Wembley, Site Location


02/07/2018
 Site Location
 1:2500
 03/11/17
 P03

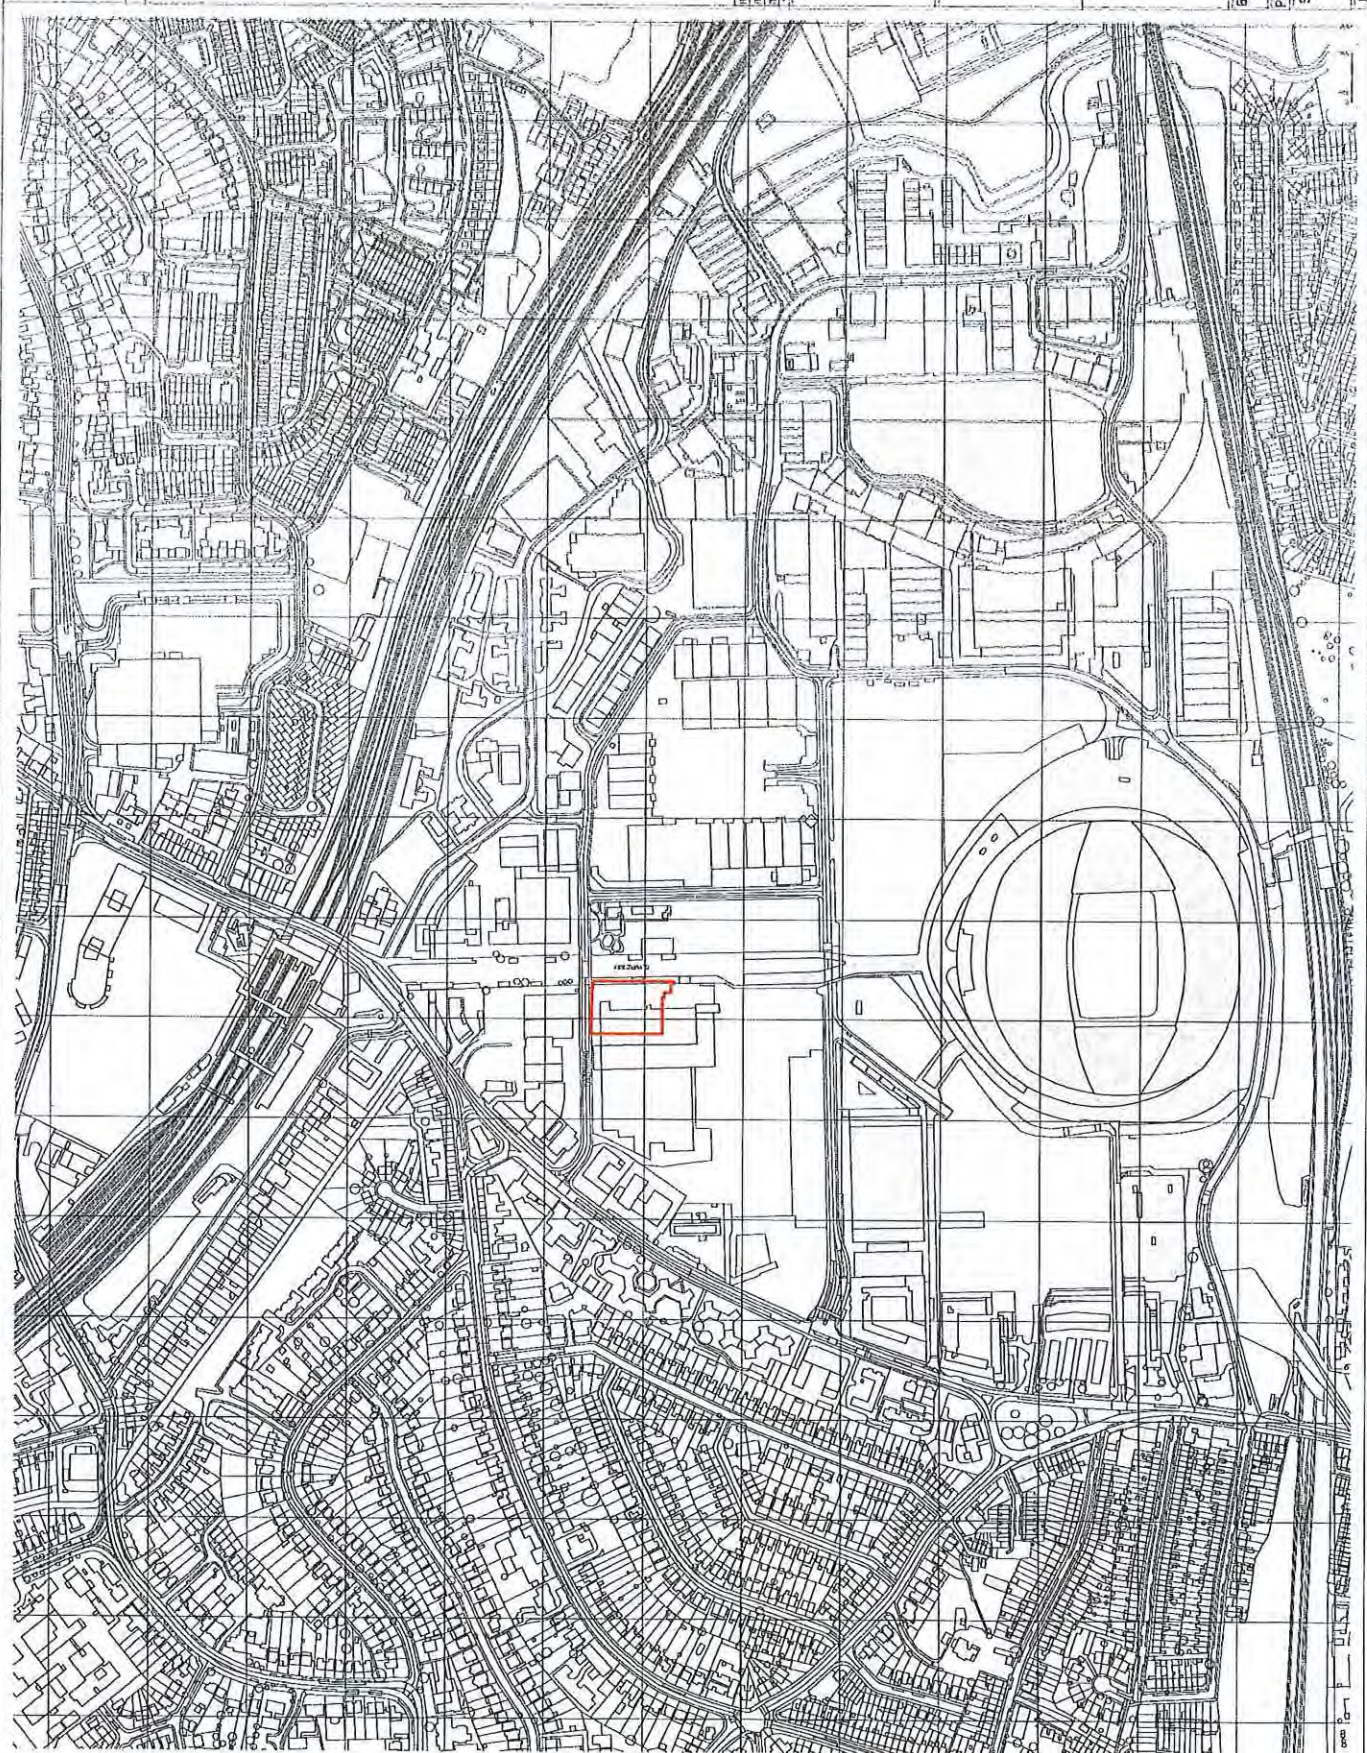

**icensed Areas
shown in RED**

Key	SYMBOLS FOR FIRE REQUIREMENTS
(E)	EMERGENCY LIGHT
(E)	MAINTAINED EMERGENCY LIGHT
(E)	ILLUMINATED FIRE EXIT (E)
(E)	BREAK GLASS CALL POINT
(SD)	SMOKE DETECTOR (with sounder)
(HD)	HEAT DETECTOR (with sounder)
(E)	FIRE BLANKET
(E)	CARBON DIOXIDE FIRE EXTINGUISHER
(E)	8 LITRE WATER FIRE EXTINGUISHER
(E)	DRY POWDER FIRE EXTINGUISHER
(E)	FOAM FIRE EXTINGUISHER
(E)	FIRE ALARM PANEL, PORTABLE LOOP INIT, ONE MESSAGE VOICE SOUNDER INTERFACED TO MAIN FIRE ALARM SYSTEM
(E)	PORTABLE FIRE FIGHTING EQUIPMENT TO CONFORM TO BS EN PARTS 1 TO 6 AND B5 780: 1996
(E)	FIRE ALARM AND DETECTION SYSTEM TO BS5811 PT1 & PT2, L3 AND INTERLINKED WITH ENTIRE BUILDING FIRE ALARM SYSTEM.
(E)	EMERGENCY LIGHTING TO BS5266 PART1

MAXIMUM OCCUPANCY 208 PEOPLE

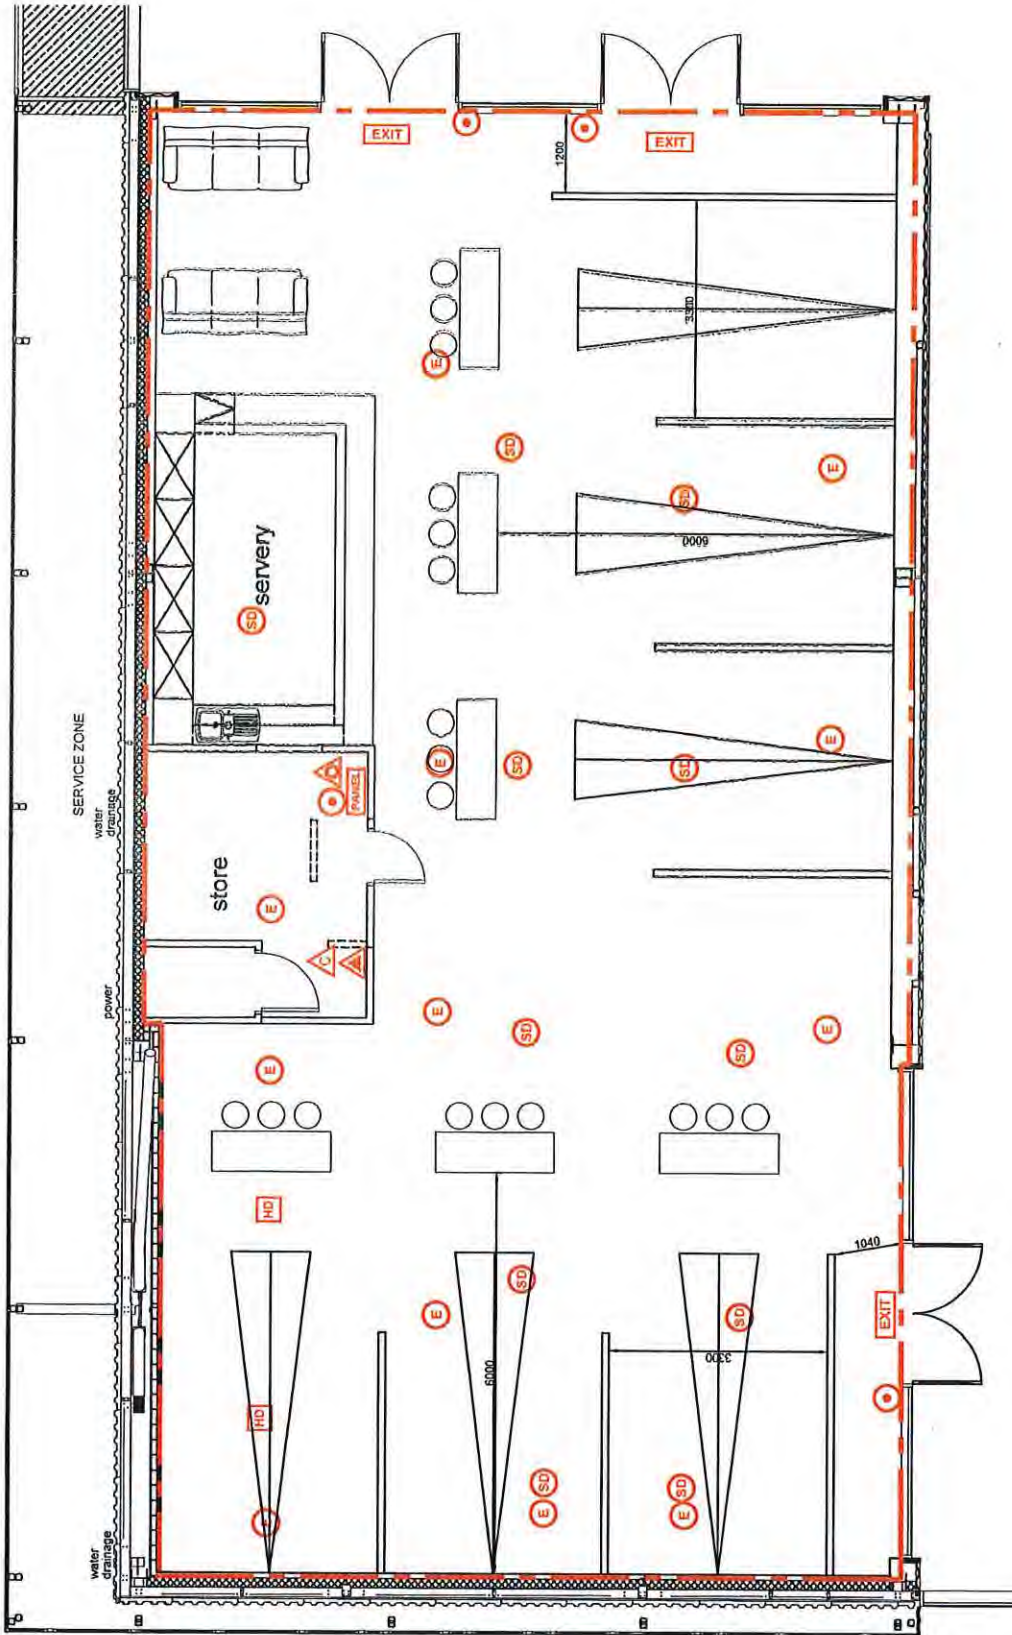

Bad Axe Throwing
Boxpark
Wembley

Plan As Proposed
LICENSING PLAN
Scale: 1:75@A3
1497-19-0016
Date: July 19

LABC
Licensing Architectural
Drawing Contractors

Darren Law
Architecture
81 Steed Close Paignton TQ4 7SP
01803 844961 info@dl-arch.co.uk